



Third Design Group, P.C.
4007-C Knight Boulevard
Greensboro, NC 27407
Telephone 336-216-5022
Fax 336-216-5010
NC Architectural No. 4029
NC Engineering No. 01148




Security National Properties
2301 West Meadowview Road
Greensboro, North Carolina 27407

North Carolina Works
Career Center
for the
City of Greensboro, North Carolina

Rev.	Date	Revised/Added
1		
2		
3		
4		
5		
6		
7		
8		
9		
10		

FIRST FLOOR PLAN
A1.1
Sheet
Date: OCTOBER 3, 2013
Project: CAREER CENTER
Job Number: 14-075
Street:

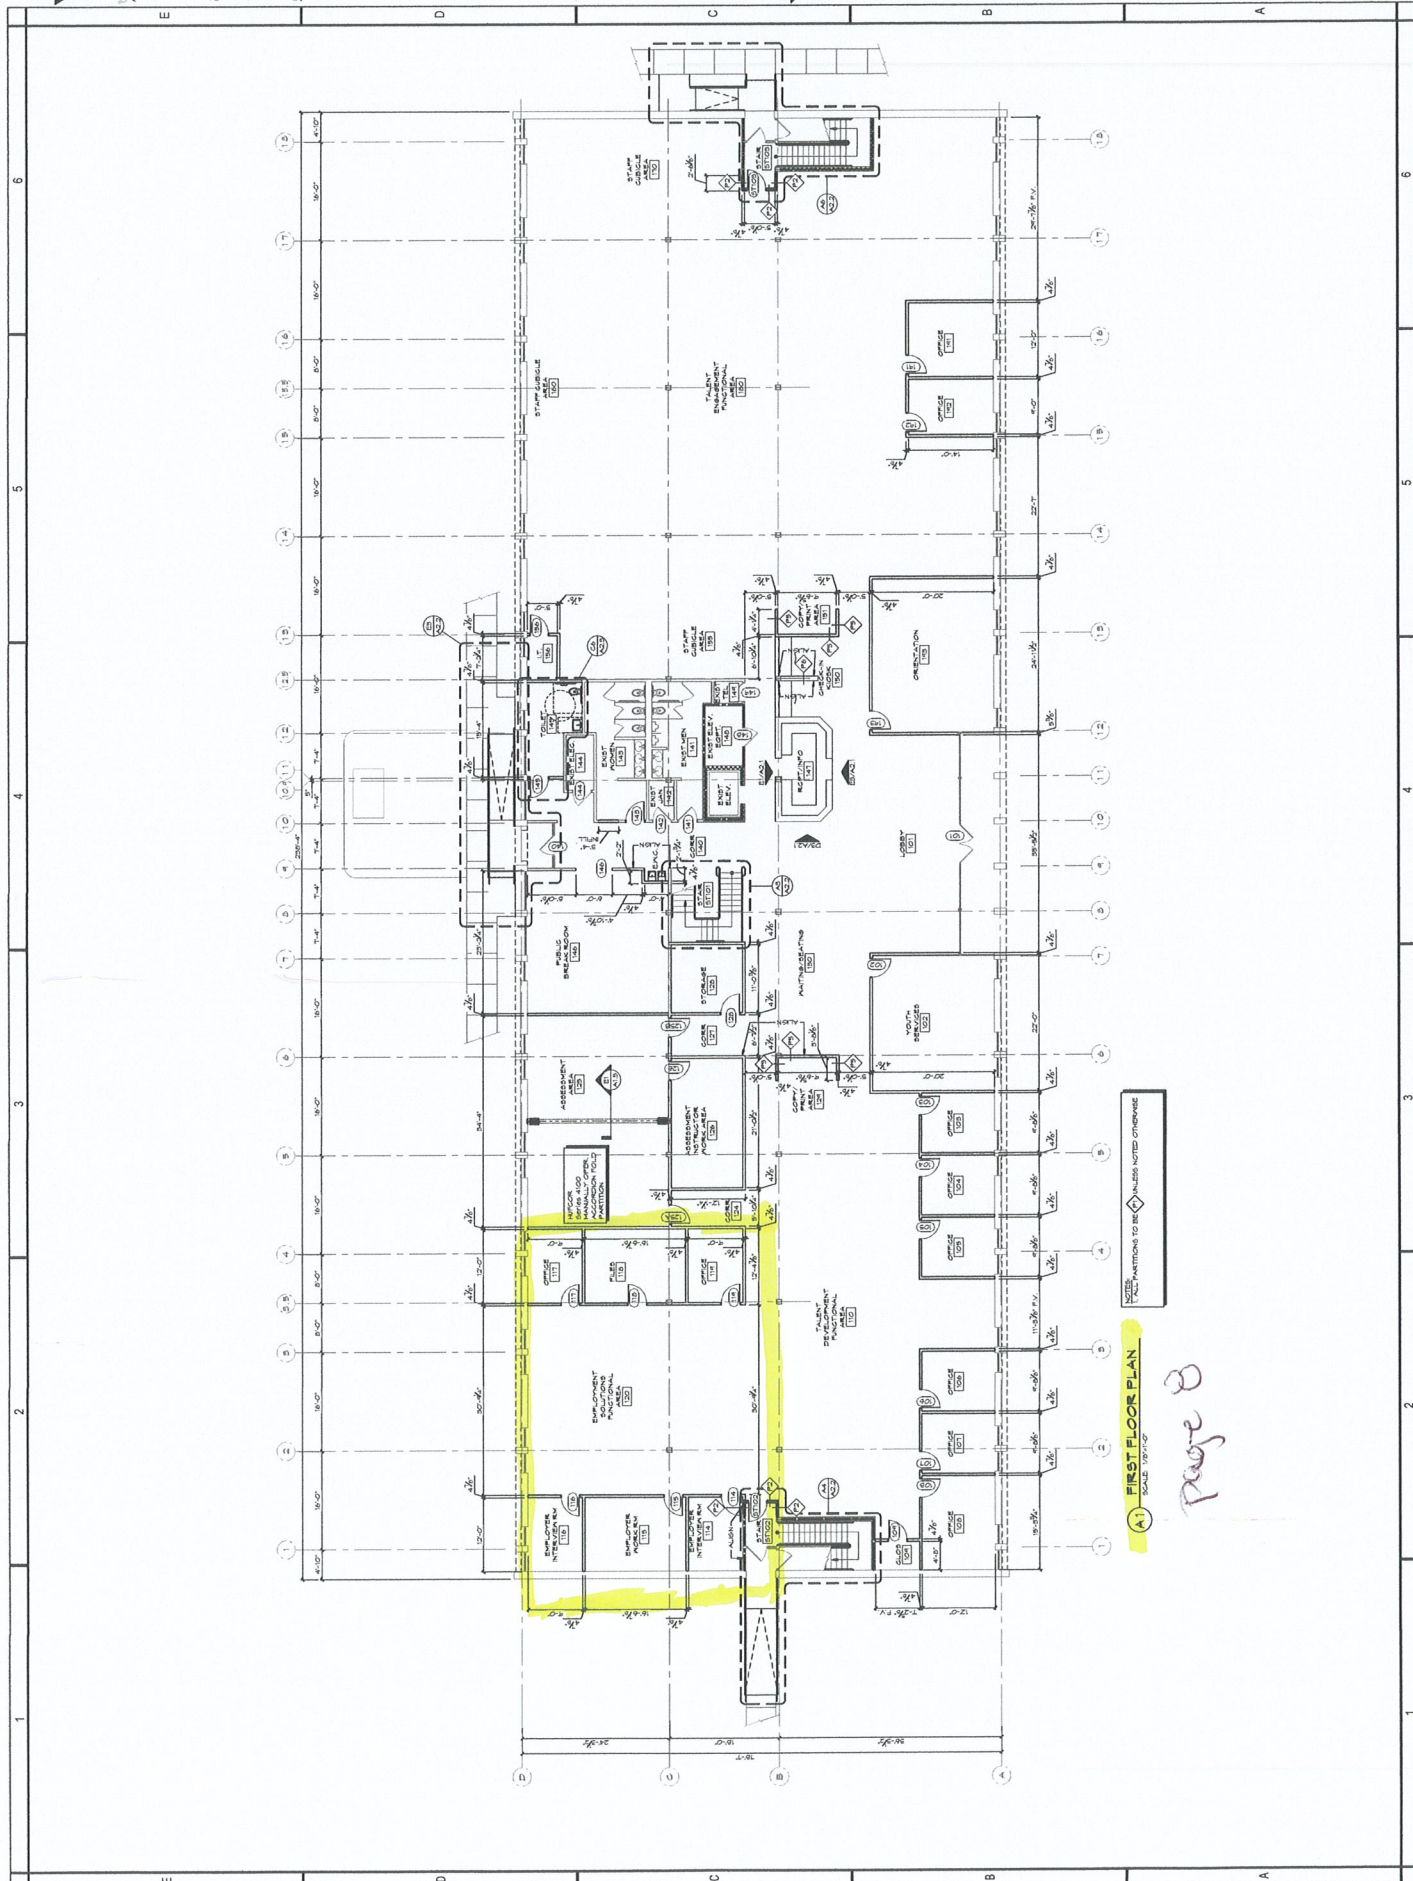



7744 Design Group, P.C.
4607-C Roger Boulevard
Greensboro, NC 27407
Phone: 336-733-8010
Fax: 336-733-8011
www.7744designgroup.com
NC Professional No. 01108




Security National Properties
2301 West Meadowview Road
Greensboro, North Carolina 27407

North Carolina Works
Career Center
for the
City of Greensboro, North Carolina

REVISIONS
NO. DATE DESCRIPTION
1 08/28/2018

SECOND FLOOR PLAN
DATE: OCTOBER 3, 2018
DRAWN: JES [CHECKED: JES]
DESIGNED: JES [CHECKED: JES]
PROJECT: CAREER CENTER
SHEET: A1.2

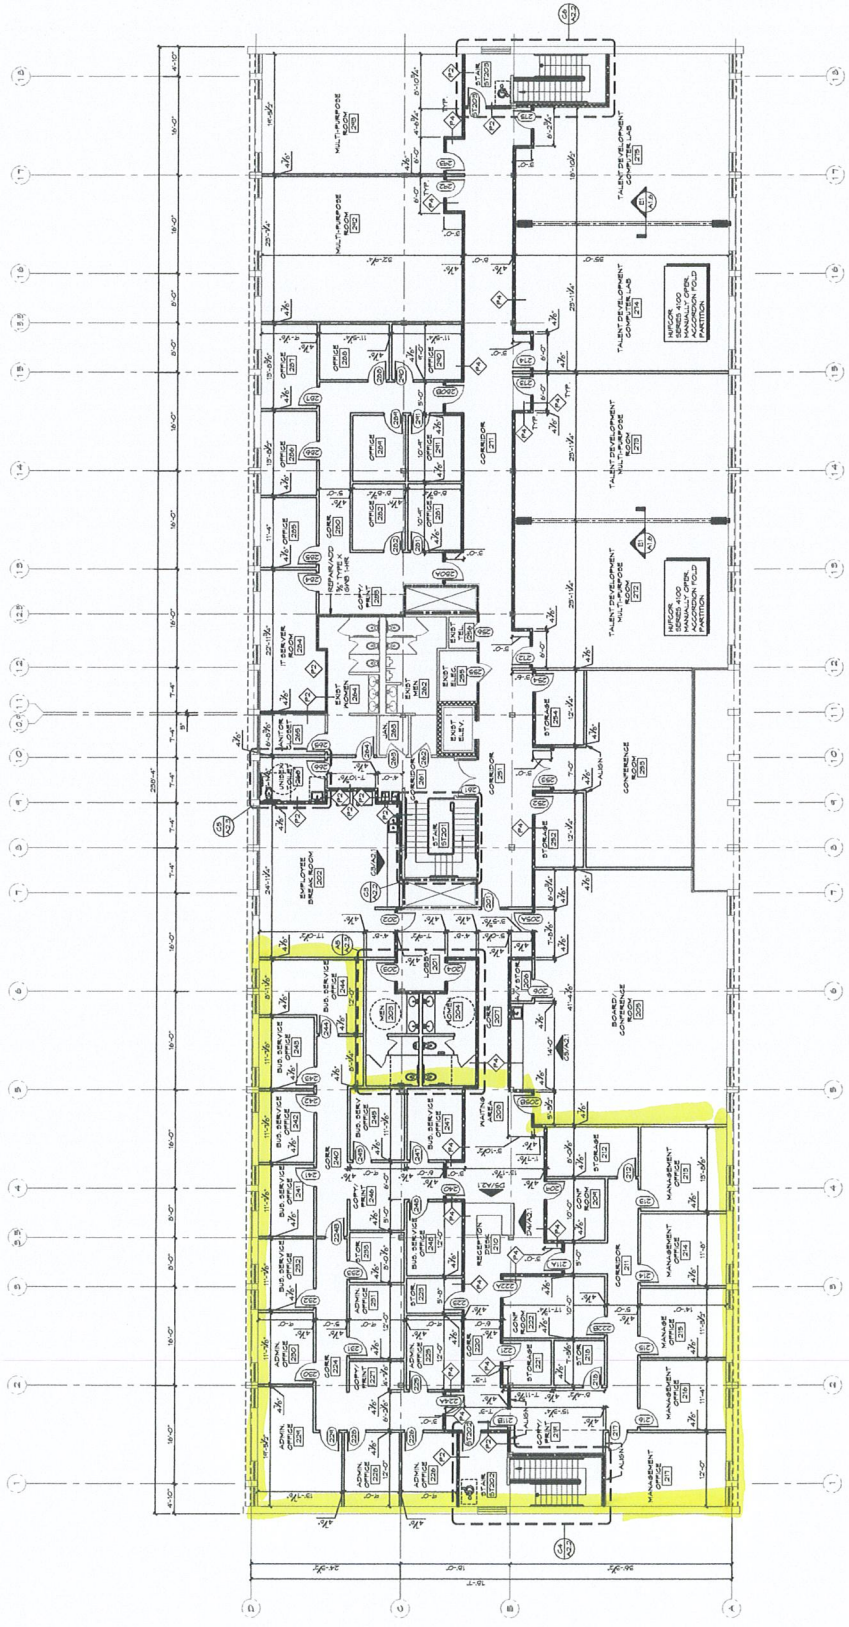

ALL PARTITIONS TO BE 1/2\"/>

A1 SECOND FLOOR PLAN
SCALE: 1/8\"/>

page 9